


ADJOINING SHEETS: 2007/18-200-L/100

6 486 000m E 486 000 m N

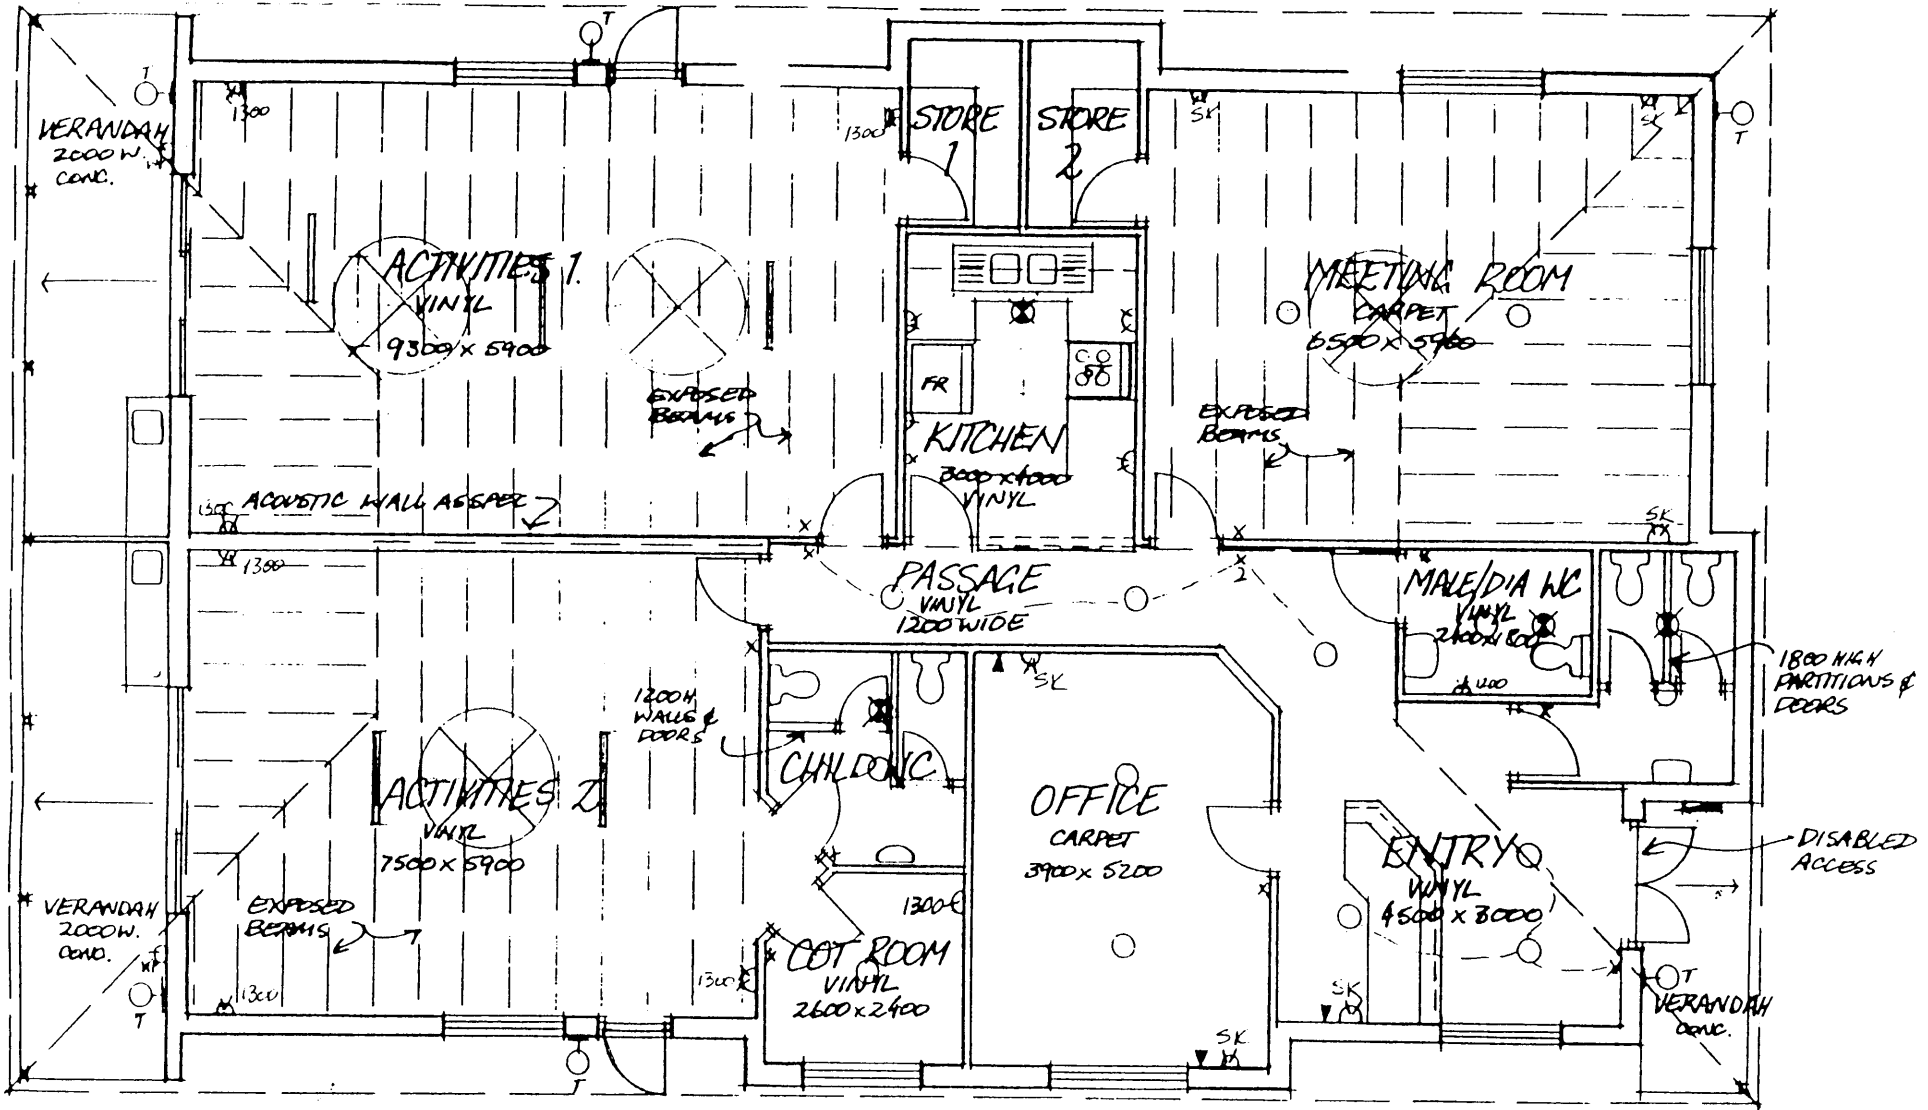


PLAN (INDICATIVE ONLY) 1:100


ELECTRICAL LEGEND

- SURFACE MOUNTED INCANDESCENT LUMINAIRE
- 36W SURFACE FLUORESCENT LUMINAIRE WITH PRISMATIC DIFFUSER
- ⊙ MOVEMENT ACTIVATED SECURITY LIGHT ON TIME CLOCK
- x LIGHT SWITCH LOCATION
- MAIN SWITCHBOARD


- ⊗ CEILING FAN SPECIFIED
- ⊘ EXHAUST FAN SPECIFIED
- ▽ PHONE POINT BY PRINCIPAL

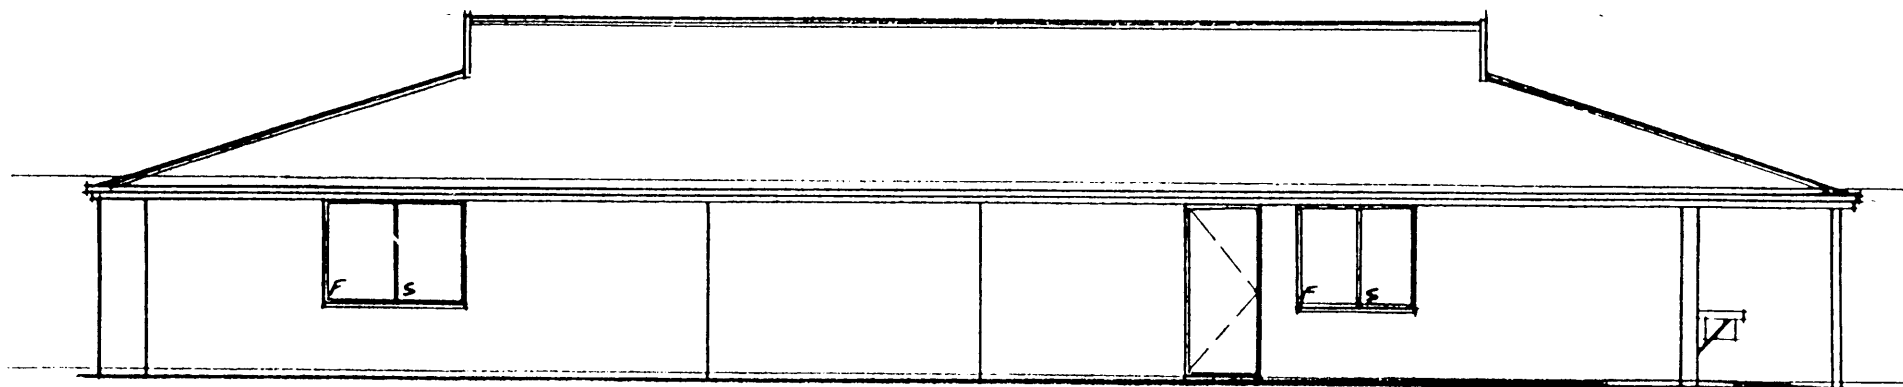


SIDE ELEVATION 1:100

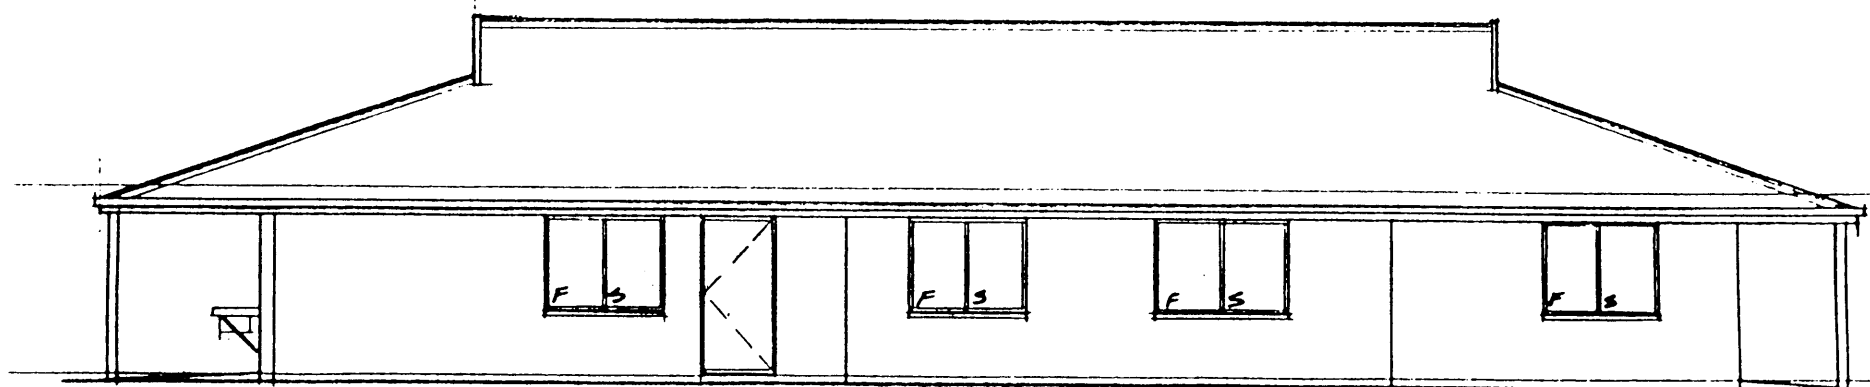

SIDE ELEVATION 1:100

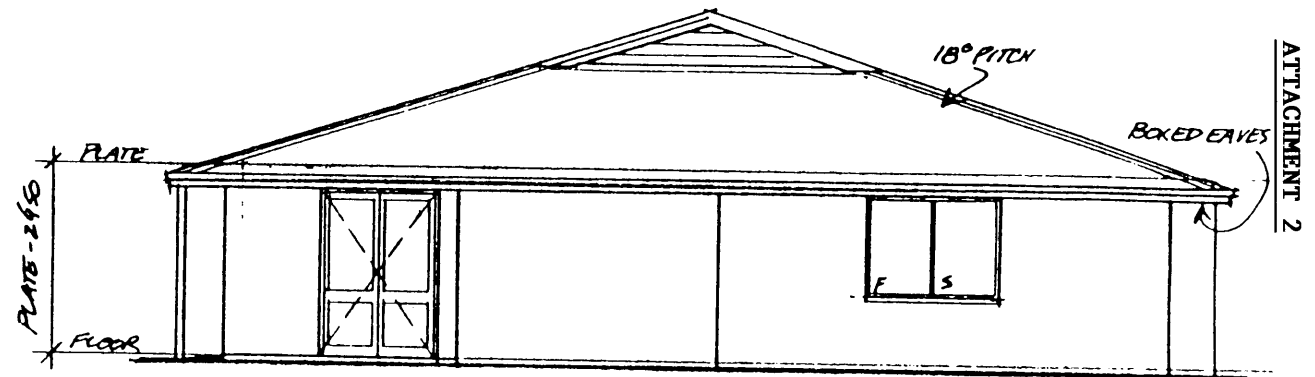


FRONT ELEVATION 1:100

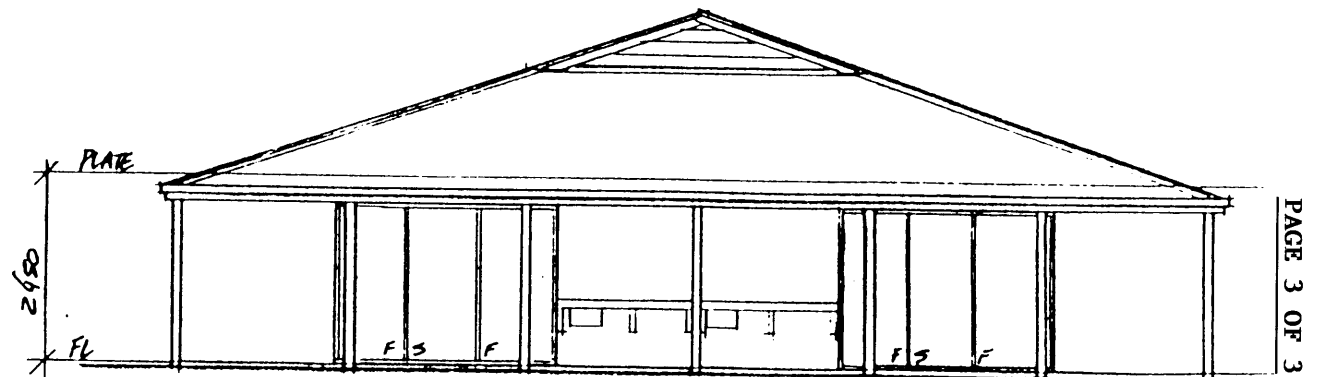

REAR ELEVATION 1:100

PROPOSED - "COMMUNITY FACILITY"
COUNCIL

Drawn by David Davies

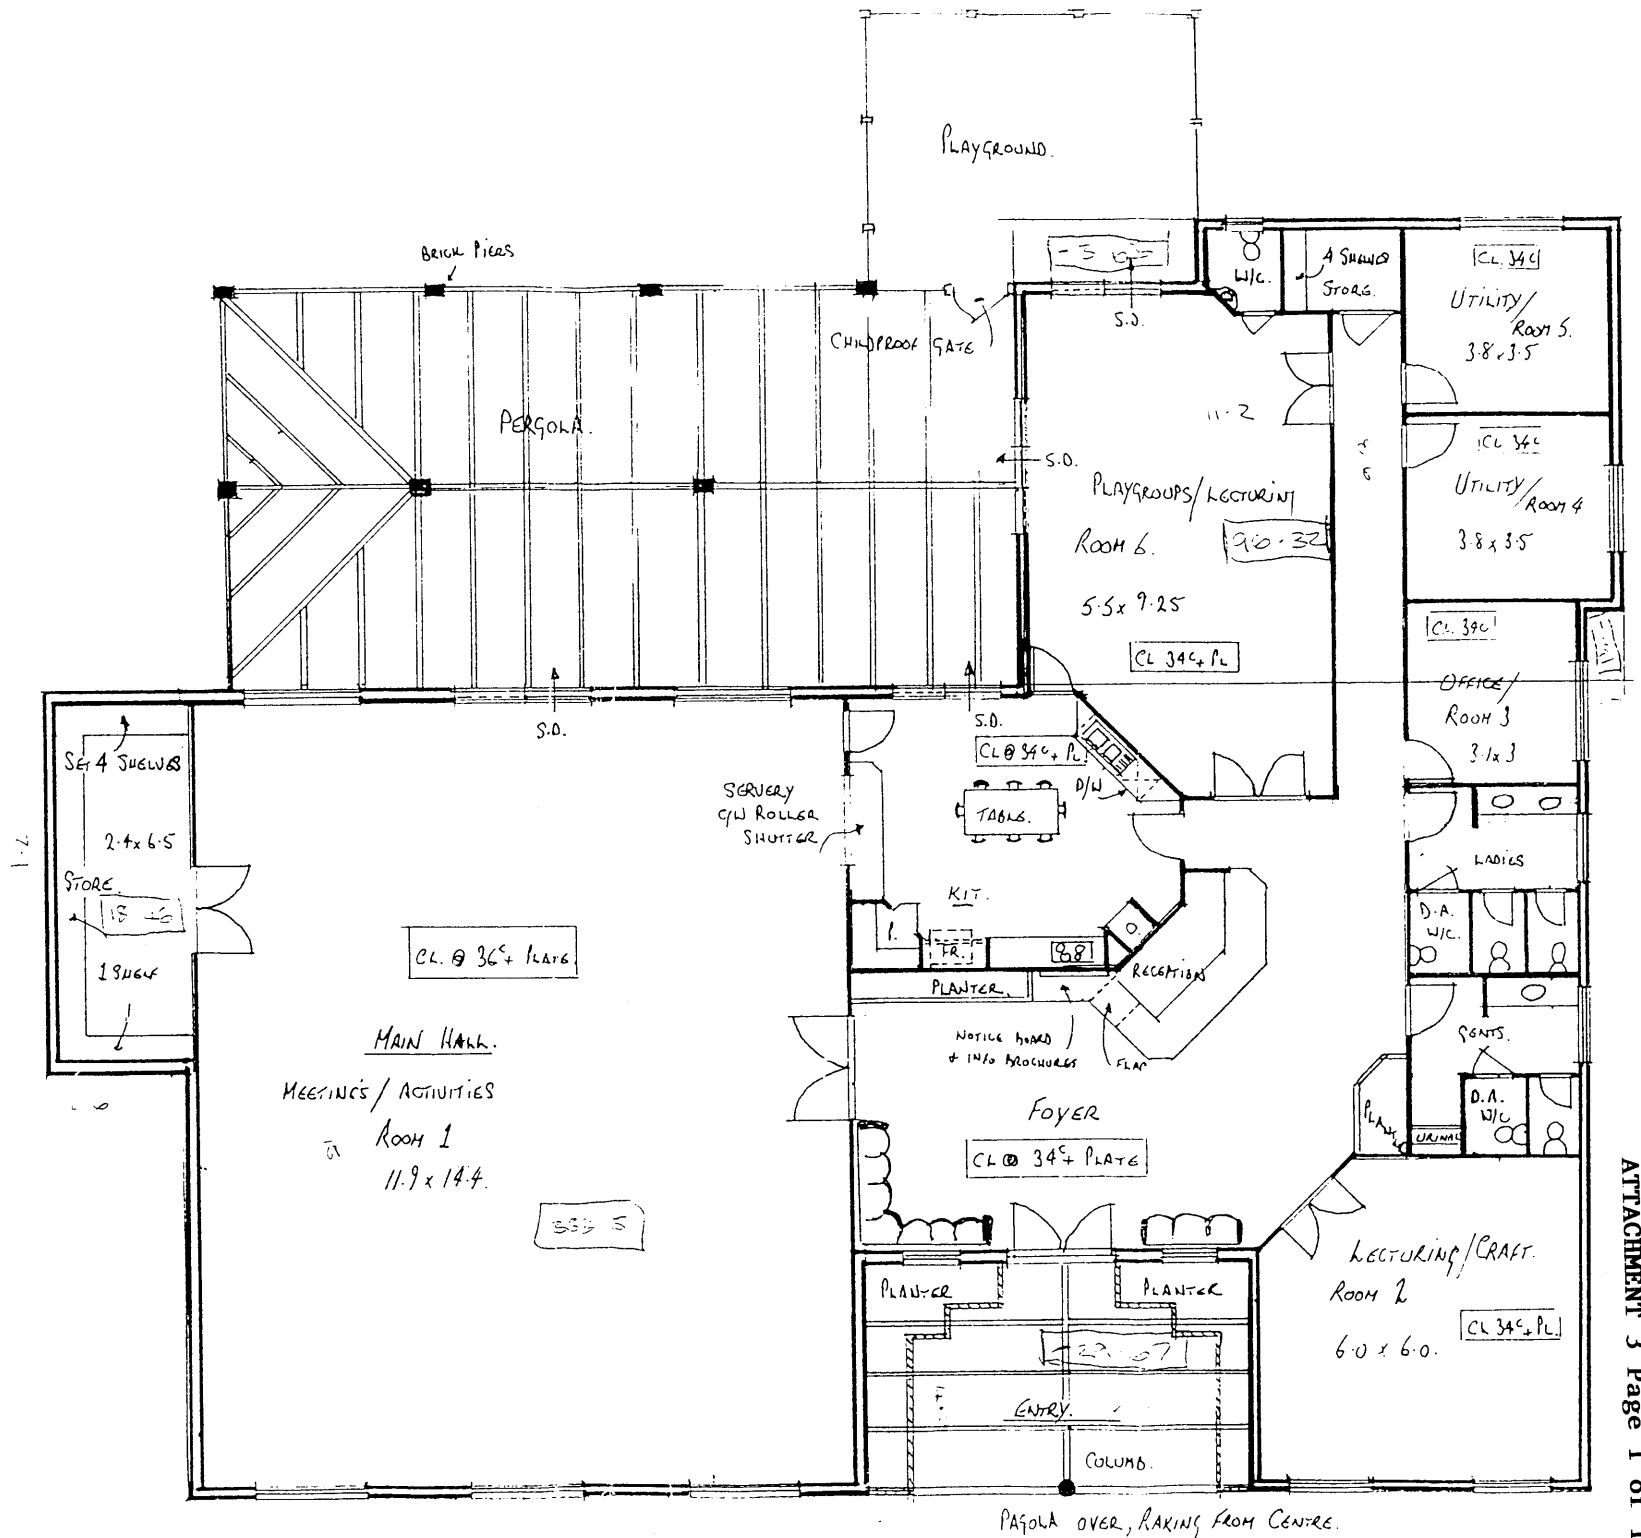

PERGOLA OVER, RAKING FROM CENTRE.